



CITY OF ANN ARBOR ENGINEERING

2019 MISC UTILITY PROJECTS

ITB 4556, FILE No. 2018025



NOTES

FOR PROTECTION OF UNDERGROUND UTILITIES AND IN CONFORMANCE WITH PUBLIC ACT 174 OF 2013, THE CONTRACTOR SHALL CALL 811 OR 1-800-482-7171 A MINIMUM OF THREE FULL WORKING DAYS, EXCLUDING SATURDAYS, SUNDAYS, AND HOLIDAYS, PRIOR TO BEGINNING EACH EXCAVATION IN AREAS WHERE PUBLIC UTILITIES HAVE NOT BEEN PREVIOUSLY LOCATED. MEMBERS WILL THUS BE ROUTINELY NOTIFIED. THIS DOES NOT RELIEVE THE CONTRACTOR OF THE RESPONSIBILITY OF NOTIFYING UTILITY OWNERS WHO MAY NOT BE A PART OF THE "MISS DIG" ALERT SYSTEM.




THE UNDERGROUND LOCATIONS SHOWN FOR NATURAL GAS, TELEPHONE, ELECTRICAL POWER, CABLE TV AND FIBER OPTIC LINES ARE APPROXIMATE. THE CITY OF ANN ARBOR ASSUMES NO RESPONSIBILITY FOR THEIR ACCURATE REPRESENTATION IN THIS DRAWING. MISS DIG MUST BE CONTACTED PRIOR TO CONSTRUCTION TO LOCATE THESE UTILITIES.

THE CONSTRUCTION COVERED BY THESE PLANS SHALL CONFORM TO THE 1994 EDITION OF THE CITY OF ANN ARBOR PUBLIC SERVICES DEPARTMENT STANDARD SPECIFICATIONS, ITS DETAILS, WHICH ARE INCLUDED BY REFERENCE, AND THIS PROJECT'S CONTRACT DOCUMENTS. THE OMISSION OF ANY CURRENT STANDARD DETAIL DOES NOT RELIEVE THE CONTRACTOR FROM THIS REQUIREMENT.

SHEET LIST TABLE	
SHEET NUMBER	SHEET TITLE
1	COVER SHEET
2	STANDARD NOTES
3	LEGEND
4	WATER MAIN DETAILS
5	STORM SEWER, TRENCH AND MISC. DETAILS
6 - 8	TYPICAL SECTIONS
9	TPAR WALKWAY DEVICES
10	ALTERNATE PEDESTRIAN ROUTE (APR) DETOUR
11	TPAR RAMPS
12	ALTERNATE PEDESTRIAN ROUTE (APR) BYPASS
BUCHHOLZ COURT	
13	MAINTENANCE OF TRAFFIC
14	REMOVALS
15	WATER MAIN PLAN AND PROFILE
16	ROAD
CEDAR BEND DRIVE	
17	REMOVALS AND MAINTENANCE OF TRAFFIC
18	WATER MAIN PLAN AND PROFILE
19	ROAD
MAYWOOD AVENUE	
20	MAINTENANCE OF TRAFFIC
21 - 22	REMOVALS
23 - 26	WATER MAIN PLAN AND PROFILE
27 - 29	STORM SEWER PLAN AND PROFILE
30 - 31	ROAD

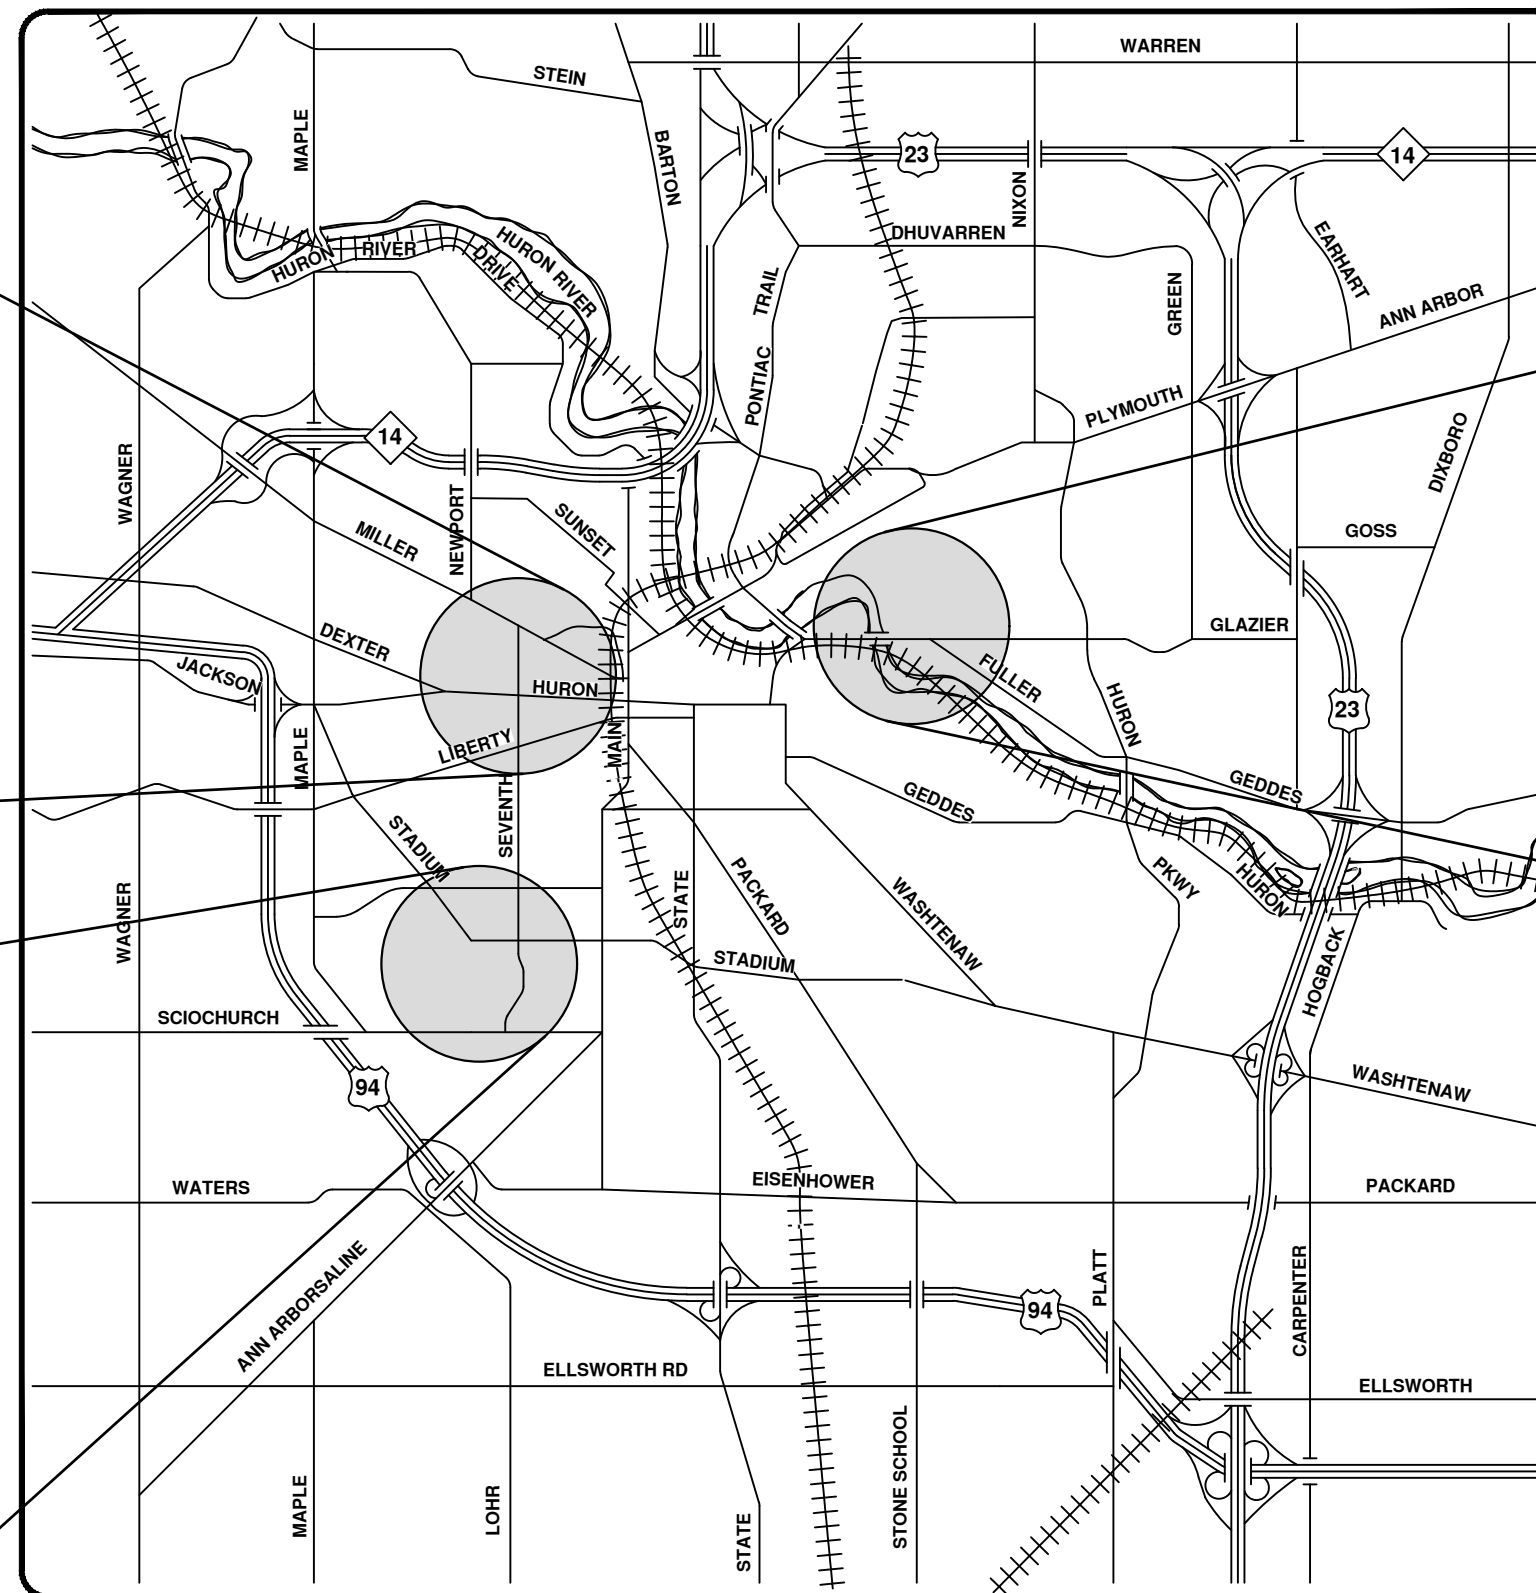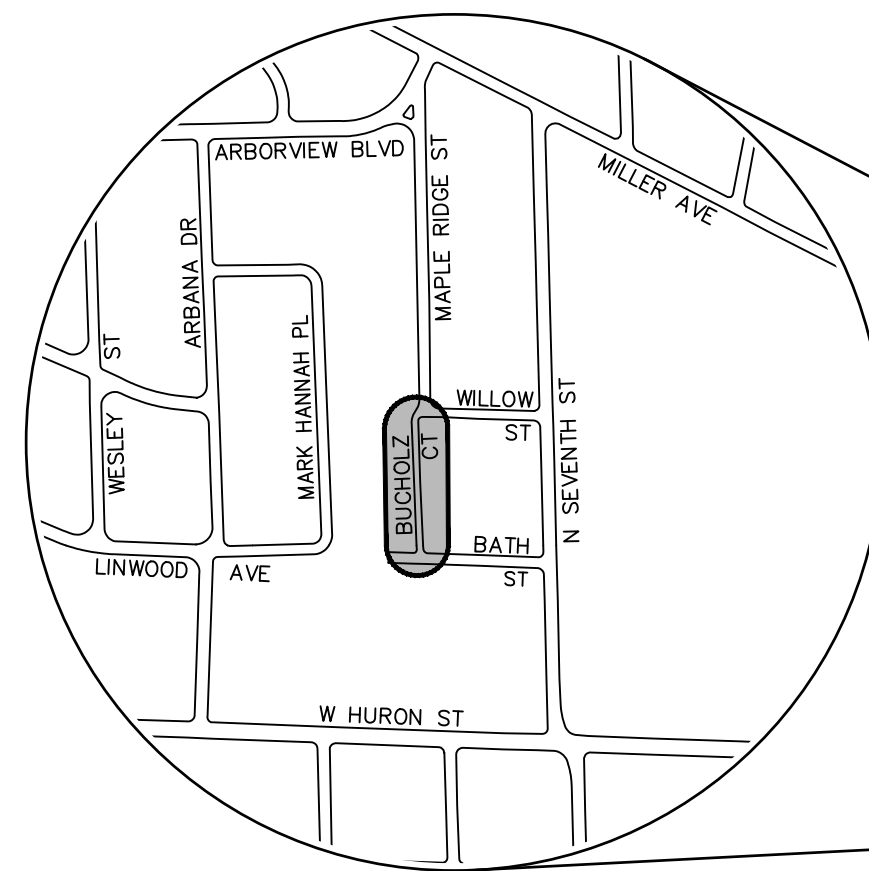


VICINITY MAP

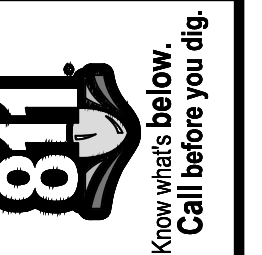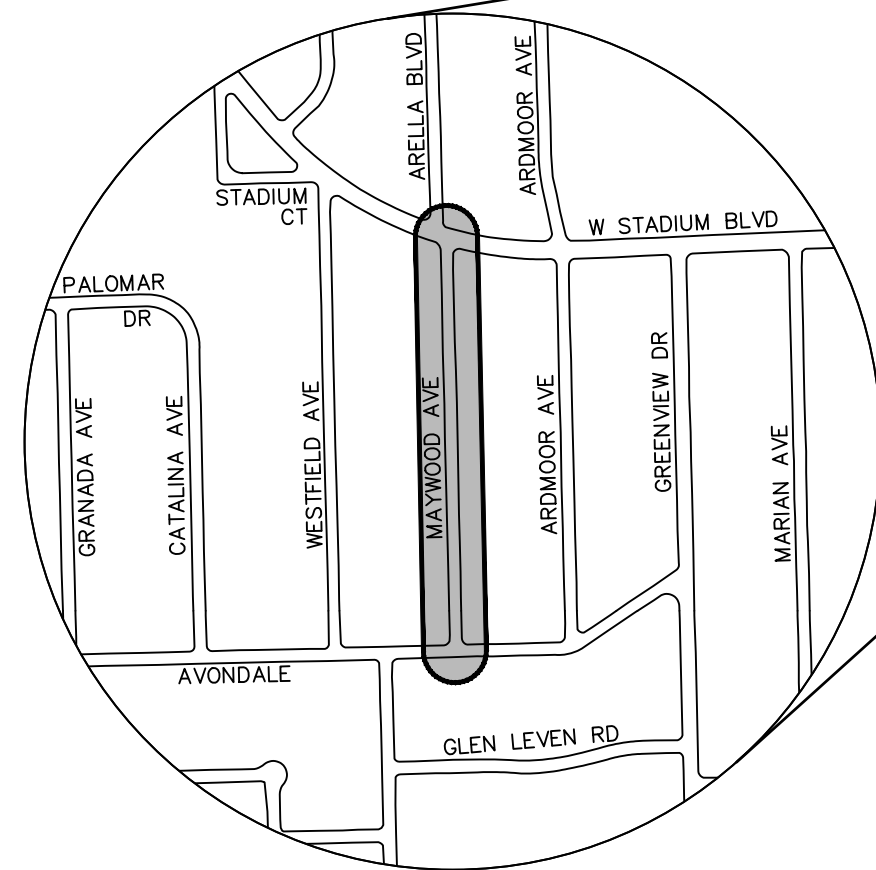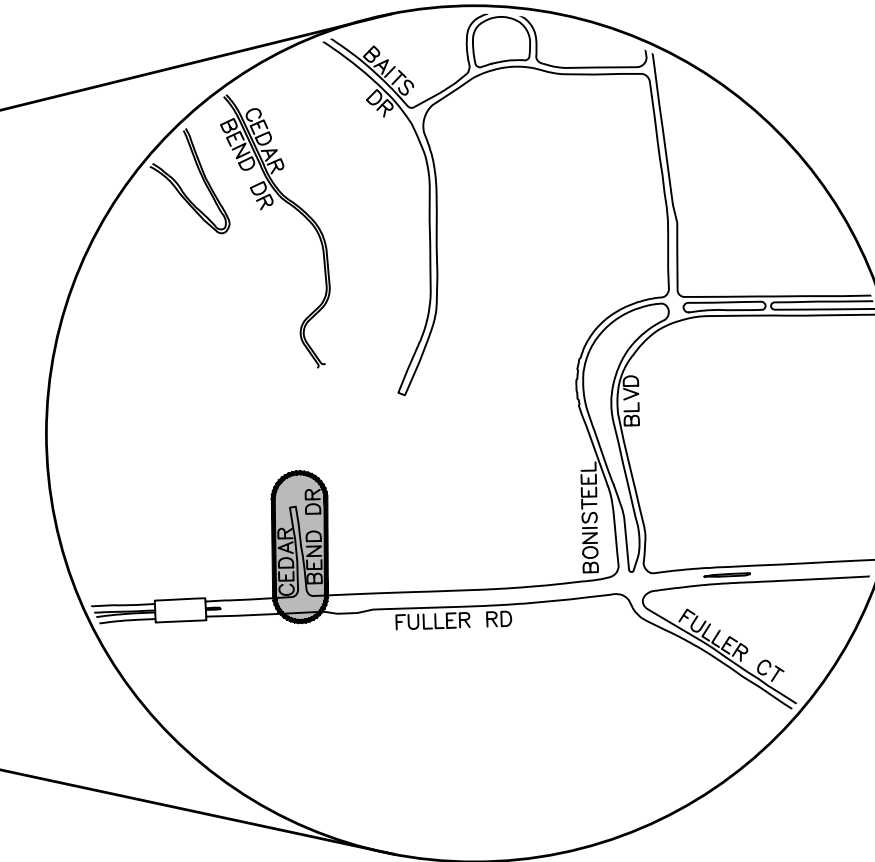

REV.	DATE	DESCRIPTION
00	3-15-19	ADDENDUM #1
00	3-1-19	OUT FOR BID
		CC/DF/KB
		CEC
		TH
		TH
		CHECKED
		DRAWN

CITY OF ANN ARBOR
PUBLIC SERVICES
301 EAST HURON STREET
ANN ARBOR, MI 48106-6647
www.a2gov.org

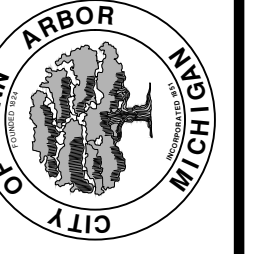

CITY OF ANN ARBOR - PUBLIC SERVICES - ENGINEERING

SCALE
DRAWING No.
2018025-1
SHEET No.
1 OF 31

PREPARED UNDER THE SUPERVISION OF
Tesha Humphriss
TESHA HUMPHRISS, P.E. - MI LICENSE No. 51103
PROJECT MANAGER
3/1/2019
DATE

